


- S/W Notes:
1. Read this drawing in conjunction with all other relevant Engineers and Architects drawings.
  2. Do not scale this drawing, use only written dimensions.
  3. Do not set out from this drawing unless specifically confirmed by the Engineers beforehand.
  4. All levels shown are to Mean Head datum (MOD).
  5. The contractor is to check all service connections before commencing any site development works.
  6. The Engineer is to be informed of discrepancies that may arise before the contractor commences any site development works, if in doubt - ask!
  7. Manhole and road gully details to comply with Greater Dublin Regional Code of practice for Drainage Works.
  8. Refer also to the Manhole details drawings provided for further information.
  9. Where cover to pipes is less than 1.2m in roads, 1.0m in public areas and 0.9m in grassed/landscaped areas, surround the pipe 150mm of concrete.

THIS IS A PLANNING DRAWING ONLY  
AND CANNOT BE USED FOR CONSTRUCTION PURPOSES

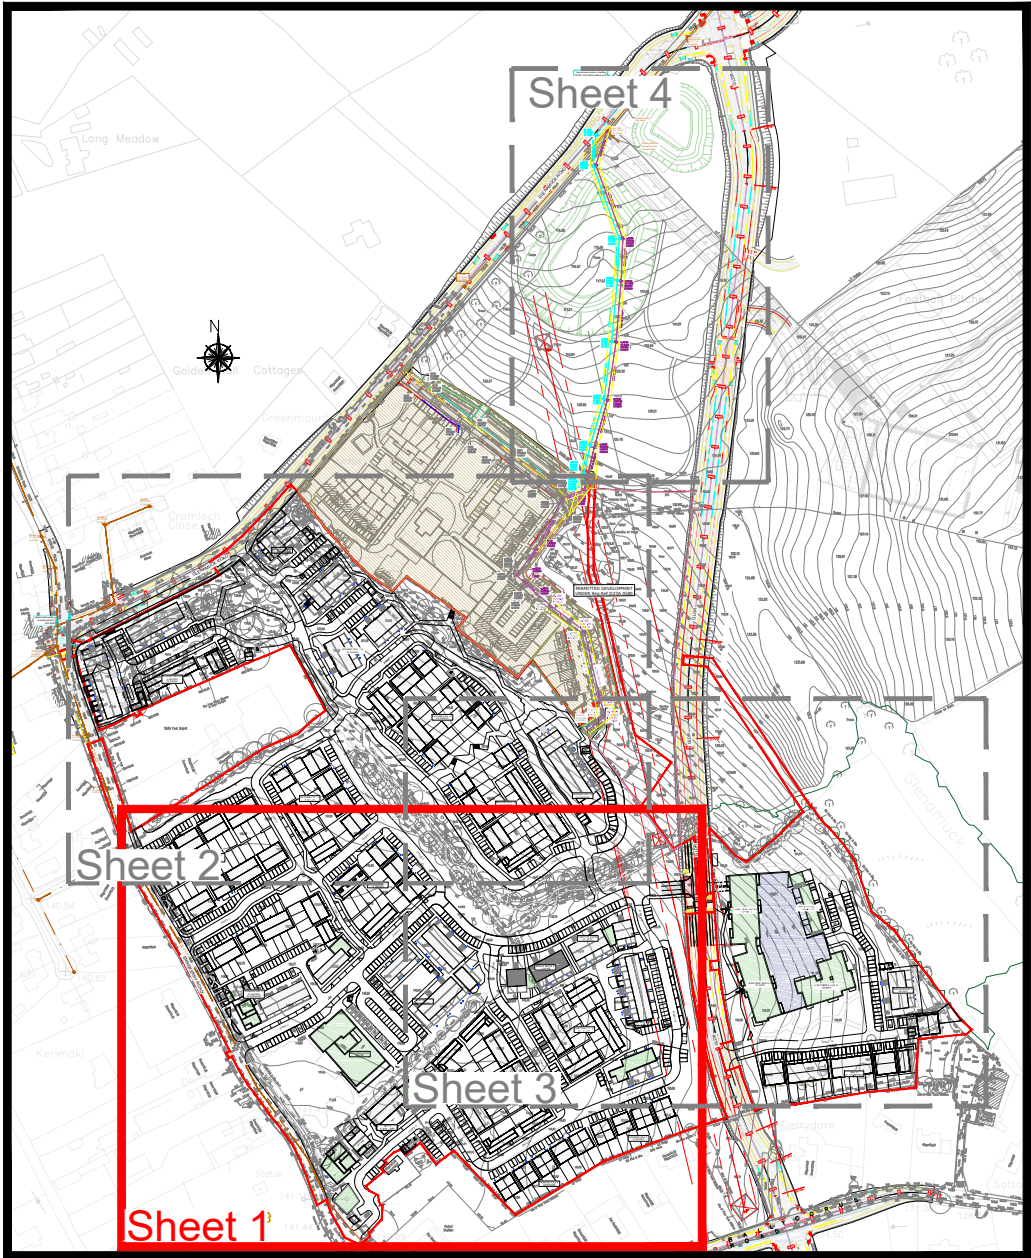

Key Plan  
A1 Scale 1:5000

S/W Drainage Legend	
S/W Manhole, Invert Level, Diameter & Gradient	
S/W Pipeline Size, Diameter & Gradient	
150mm Private House Drain/ Inspection Chamber	
SuDS 150mm Filter Drain/ Inspection Chamber	
SuDS Roadside Swale with IC and overflow connection to S/W	
SuDS Tree Pit & overflow connection to S/W	
SuDS Bio-Retention Area & overflow connection to S/W	
SuDS Green Roof	
SuDS Permeable Paving Parking Bay	
SuDS Rainwater Butt (200l)	
S/W Attenuation Storage	

REV	DATE	DESCRIPTION
<b>ROGER MULLARKEY &amp; ASSOCIATES</b> Consulting Structural and Civil Engineers		
Duncreevan, Kilcock, Co.Kildare Tel: +353 1 610 3755 Mob: +353 87 232 4917 E-mail: info@rmullarkey.ie www.rmullarkey.ie		
Project <b>KILTERNAN VILLAGE LRD</b>		
Drawing Title <b>S/W DRAINAGE LAYOUT</b> Sheet 1		Architect <b>MCORM</b> Architects
Date Oct'23	Drawn By RM	Scales 1:500 @A1
Dwg.No. 2104C/303	Stage LRD Stage 3	Rev