



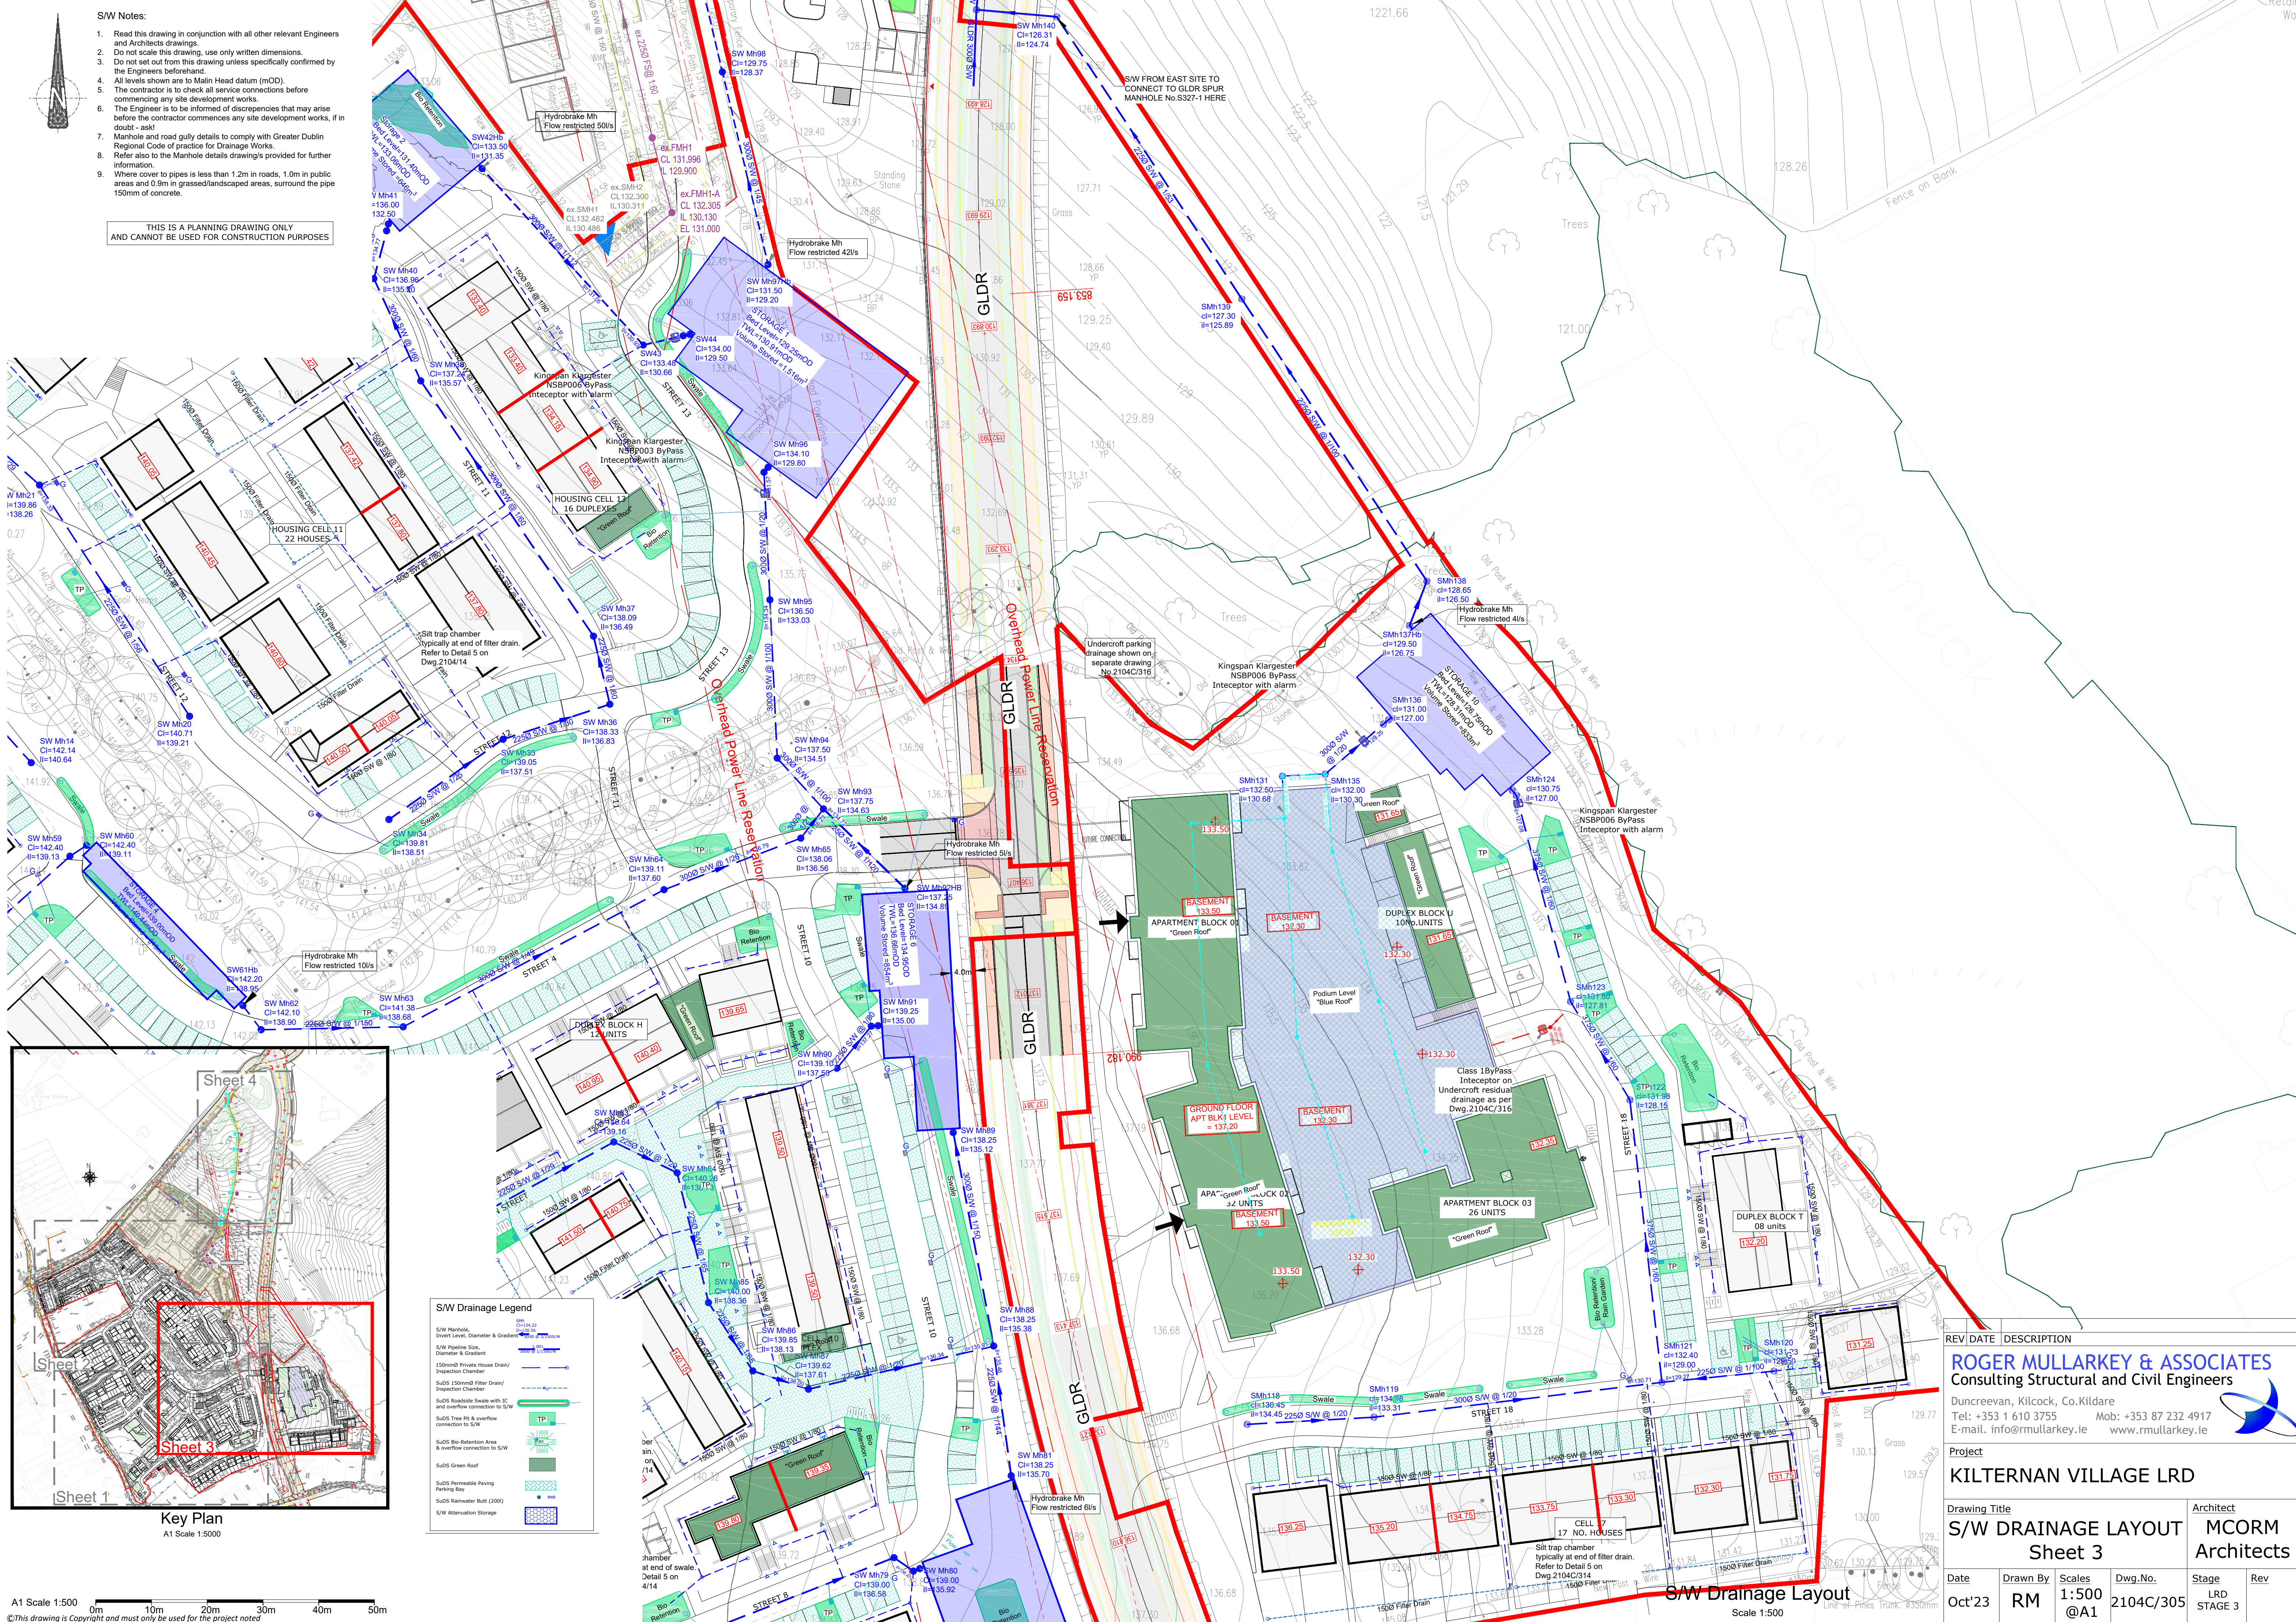

S/W Notes:

1. Read this drawing in conjunction with all other relevant Engineers and Architects drawings.
2. Do not scale this drawing, use only written dimensions.
3. Do not set out from this drawing unless specifically confirmed by the Engineers beforehand.
4. All levels shown are to Malin Head datum (mOD).
5. The contractor is to check all service connections before commencing any site development works.
6. The Engineer is to be informed of discrepancies that may arise before the contractor commences any site development works, if in doubt - ask!
7. Manhole and road gully details to comply with Greater Dublin Regional Code of practice for Drainage Works.
8. Refer also to the Manhole details drawings provided for further information.
9. Where cover to pipes is less than 1.2m in roads, 1.0m in public areas and 0.9m in grassed/landscaped areas, surround the pipe 150mm of concrete.

THIS IS A PLANNING DRAWING ONLY
AND CANNOT BE USED FOR CONSTRUCTION PURPOSES

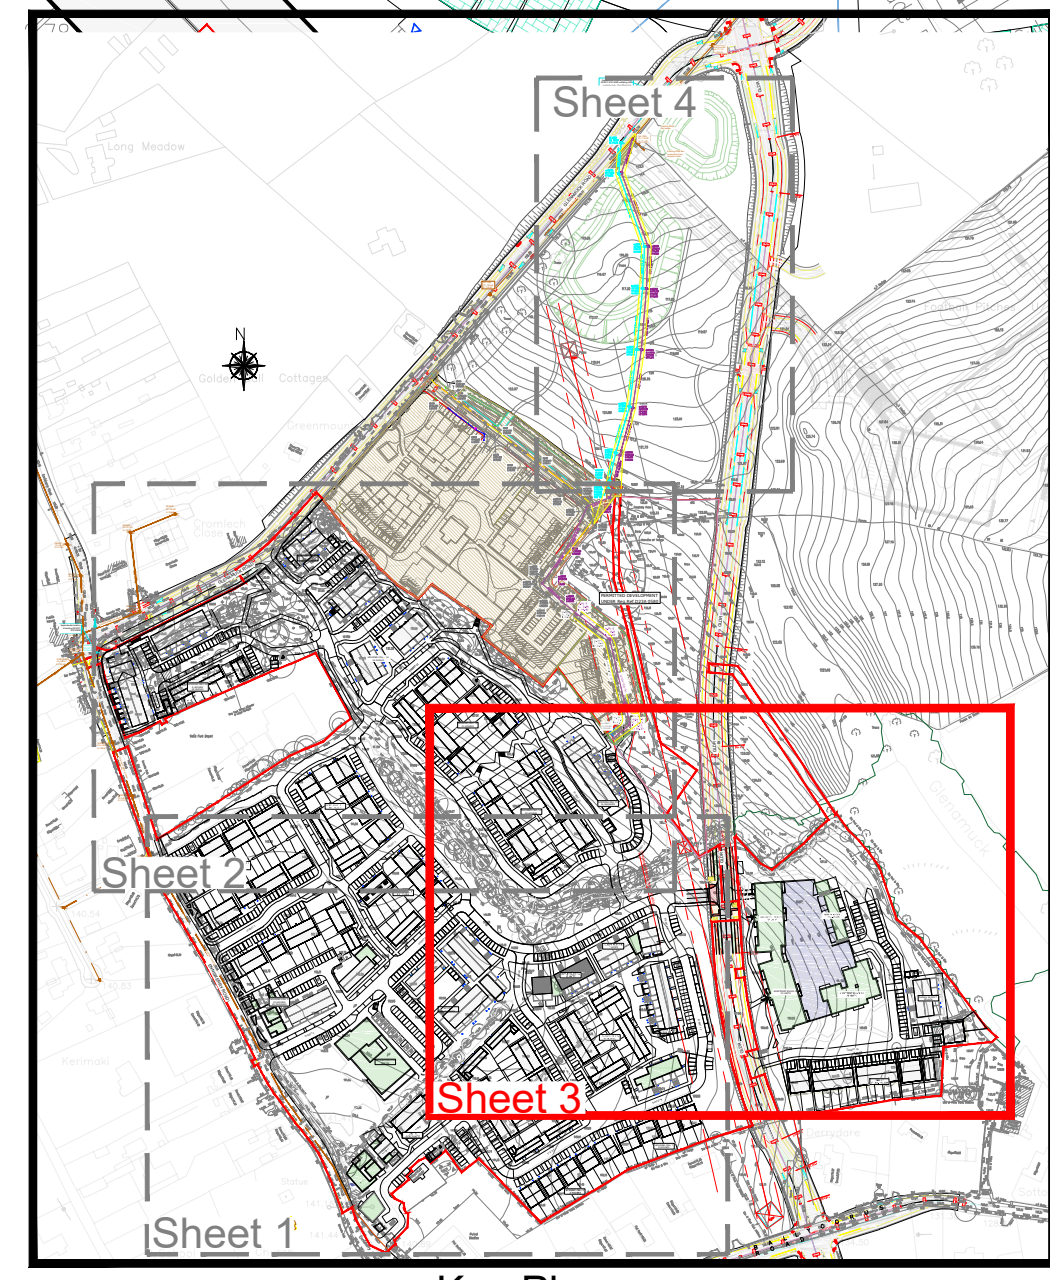

Key Plan
A1 Scale 1:5000

A1 Scale 1:500

0m 10m 20m 30m 40m 50m

© This drawing is Copyright and must only be used for the project noted

S/W Drainage Legend

S/W Manhole Invert Level, Diameter & Gradient	
S/W Pipeline Size, Diameter & Gradient	
150mm Private House Drain/ Inspection Chamber	
SUDS 150mm Filter Drain/ Inspection Chamber	
SUDS Roadside Swale with TC and overflow connection to S/W	
SUDS Tree Pit & overflow connection to S/W	
SUDS Bio-Retention Area and overflow connection to S/W	
SUDS Green Roof	
SUDS Permeable Paving Parking Bay	
SUDS Rainwater Butt (200)	
S/W Attenuation Storage	

REV/DATE		DESCRIPTION	
ROGER MULLARKEY & ASSOCIATES Consulting Structural and Civil Engineers			
Duncreevan, Kilcock, Co.Kildare			
Tel: +353 1 610 3755		Mob: +353 87 232 4917	
E-mail: info@rmullarkey.ie		www.rmullarkey.ie	
Project			
KILTERNAN VILLAGE LRD			
Drawing Title		Architect	
S/W DRAINAGE LAYOUT		MCORM	
Sheet 3		Architects	
Date	Drawn By	Scales	Dwg.No.
Oct'23	RM	1:500 @A1	2104C/305
Stage		Rev	
LRD STAGE 3			