
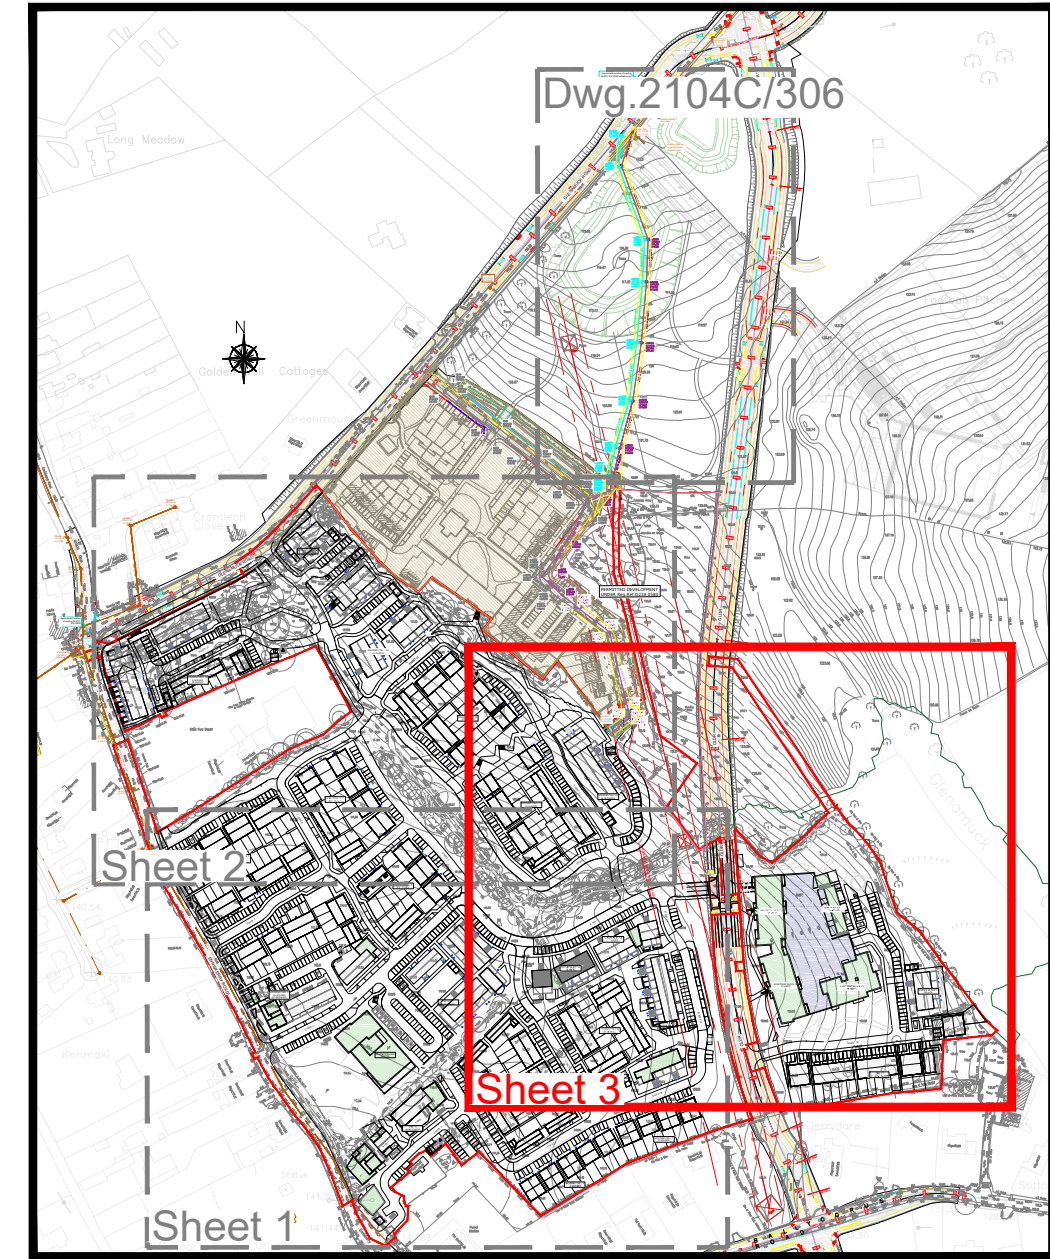
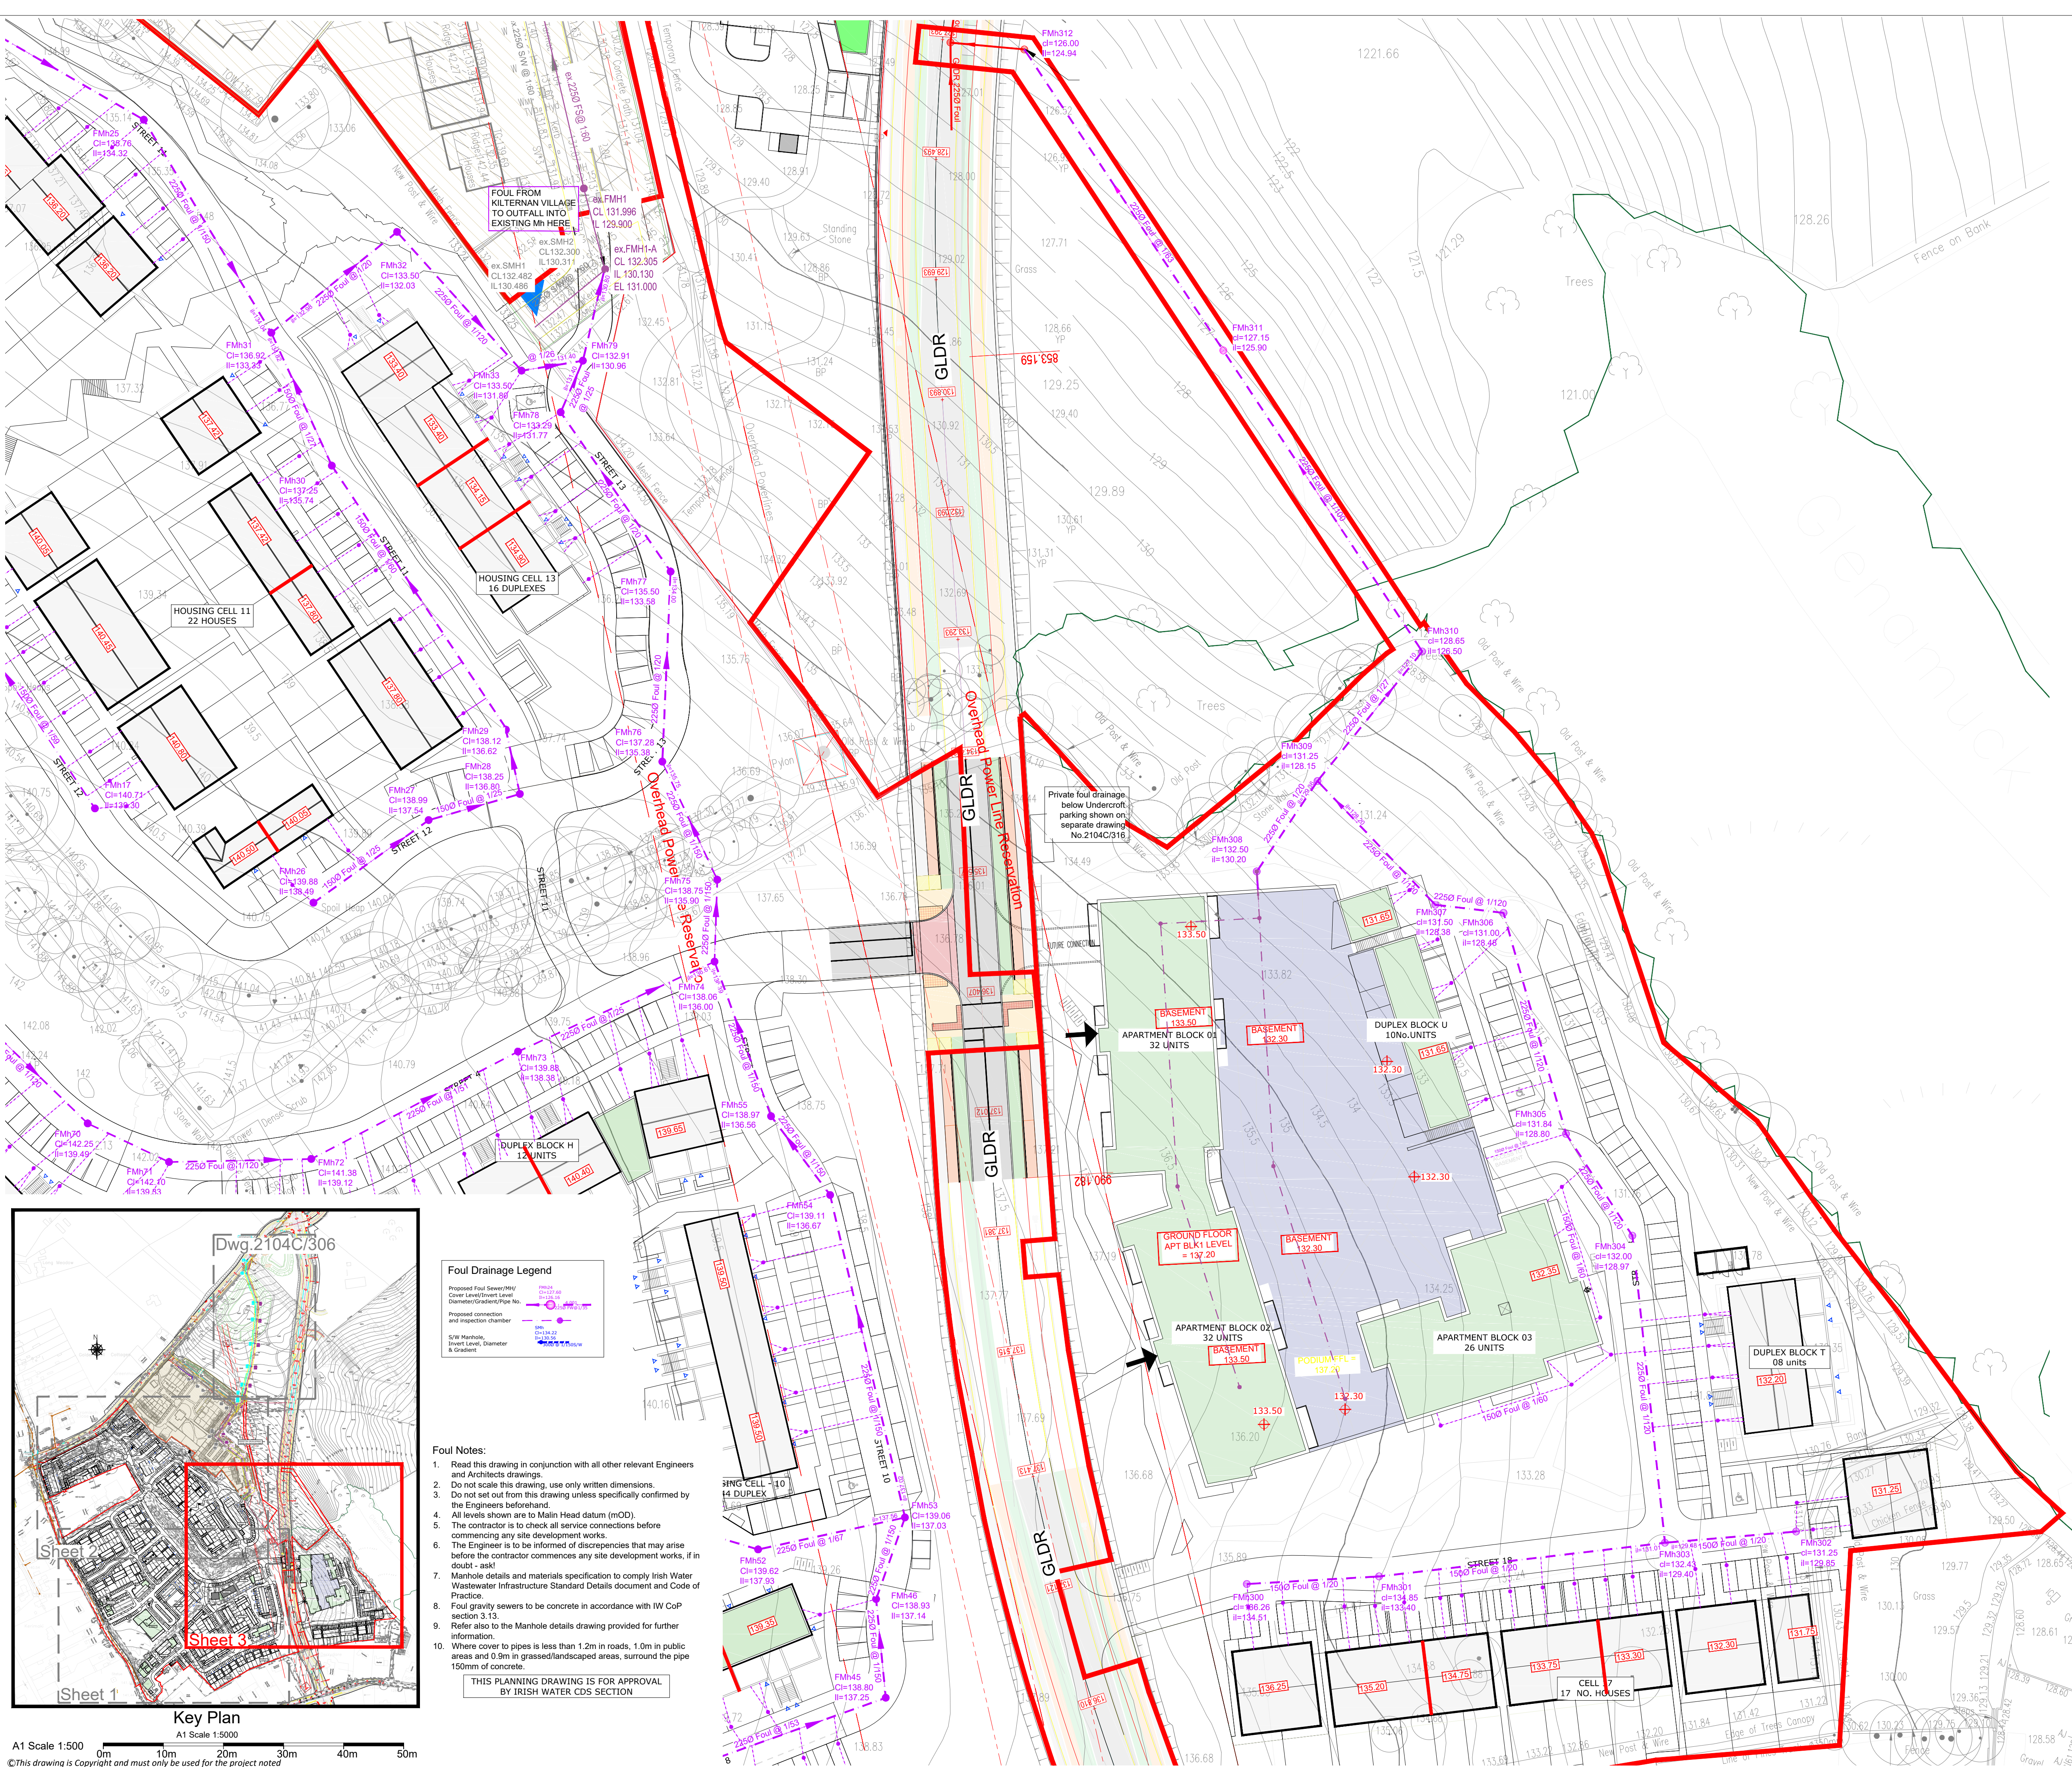


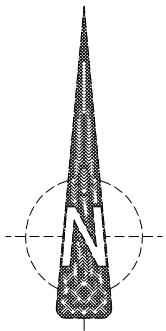

Foul Drainage Legend	
Proposed Foul Sewer (M/H)	FMH
Cover Level/Invert Level	CL/IL
Diameter/Gradient/Pipe No.	Ø/Grd/Pipe No.
Proposed connection and inspection chamber	IC
S/W Manhole	SW
Invert Level, Diameter & Gradient	IL/Ø/Grd

- Foul Notes:
1. Read this drawing in conjunction with all other relevant Engineers and Architects drawings.
 2. Do not scale this drawing, use only written dimensions.
 3. Do not set out from this drawing unless specifically confirmed by the Engineers beforehand.
 4. All levels shown are to Mean Head datum (MHD).
 5. The contractor is to check all service connections before commencing any site development works.
 6. The Engineer is to be informed of discrepancies that may arise before the contractor commences any site development works, if in doubt - ask!
 7. Manhole details and materials specification to comply Irish Water Wastewater Infrastructure Standard Details document and Code of Practice.
 8. Foul gravity sewers to be concrete in accordance with IW CoP section 3.13.
 9. Refer also to the Manhole details drawing provided for further information.
 10. Where cover to pipes is less than 1.2m in roads, 1.0m in public areas and 0.9m in grassed/landscaped areas, surround the pipe 150mm of concrete.

THIS PLANNING DRAWING IS FOR APPROVAL BY IRISH WATER CDS SECTION

REV/DATE		DESCRIPTION
ROGER MULLARKEY & ASSOCIATES Consulting Structural and Civil Engineers		
Duncreevan, Kilcock, Co.Kildare		
Tel: +353 1 610 3755		Mob: +353 87 232 4917
E-mail: info@rmullarkey.ie		www.rmullarkey.ie
Project		
KILTERNAN VILLAGE LRD		
Drawing Title		Architect
FOUL DRAINAGE LAYOUT - Sheet 3		MCORM Architects
Date	Drawn By	Scales
Oct'23	RM	1:500 @A1
Dwg.No.	Stage	Rev
2104C/309	LRD STAGE 3	